


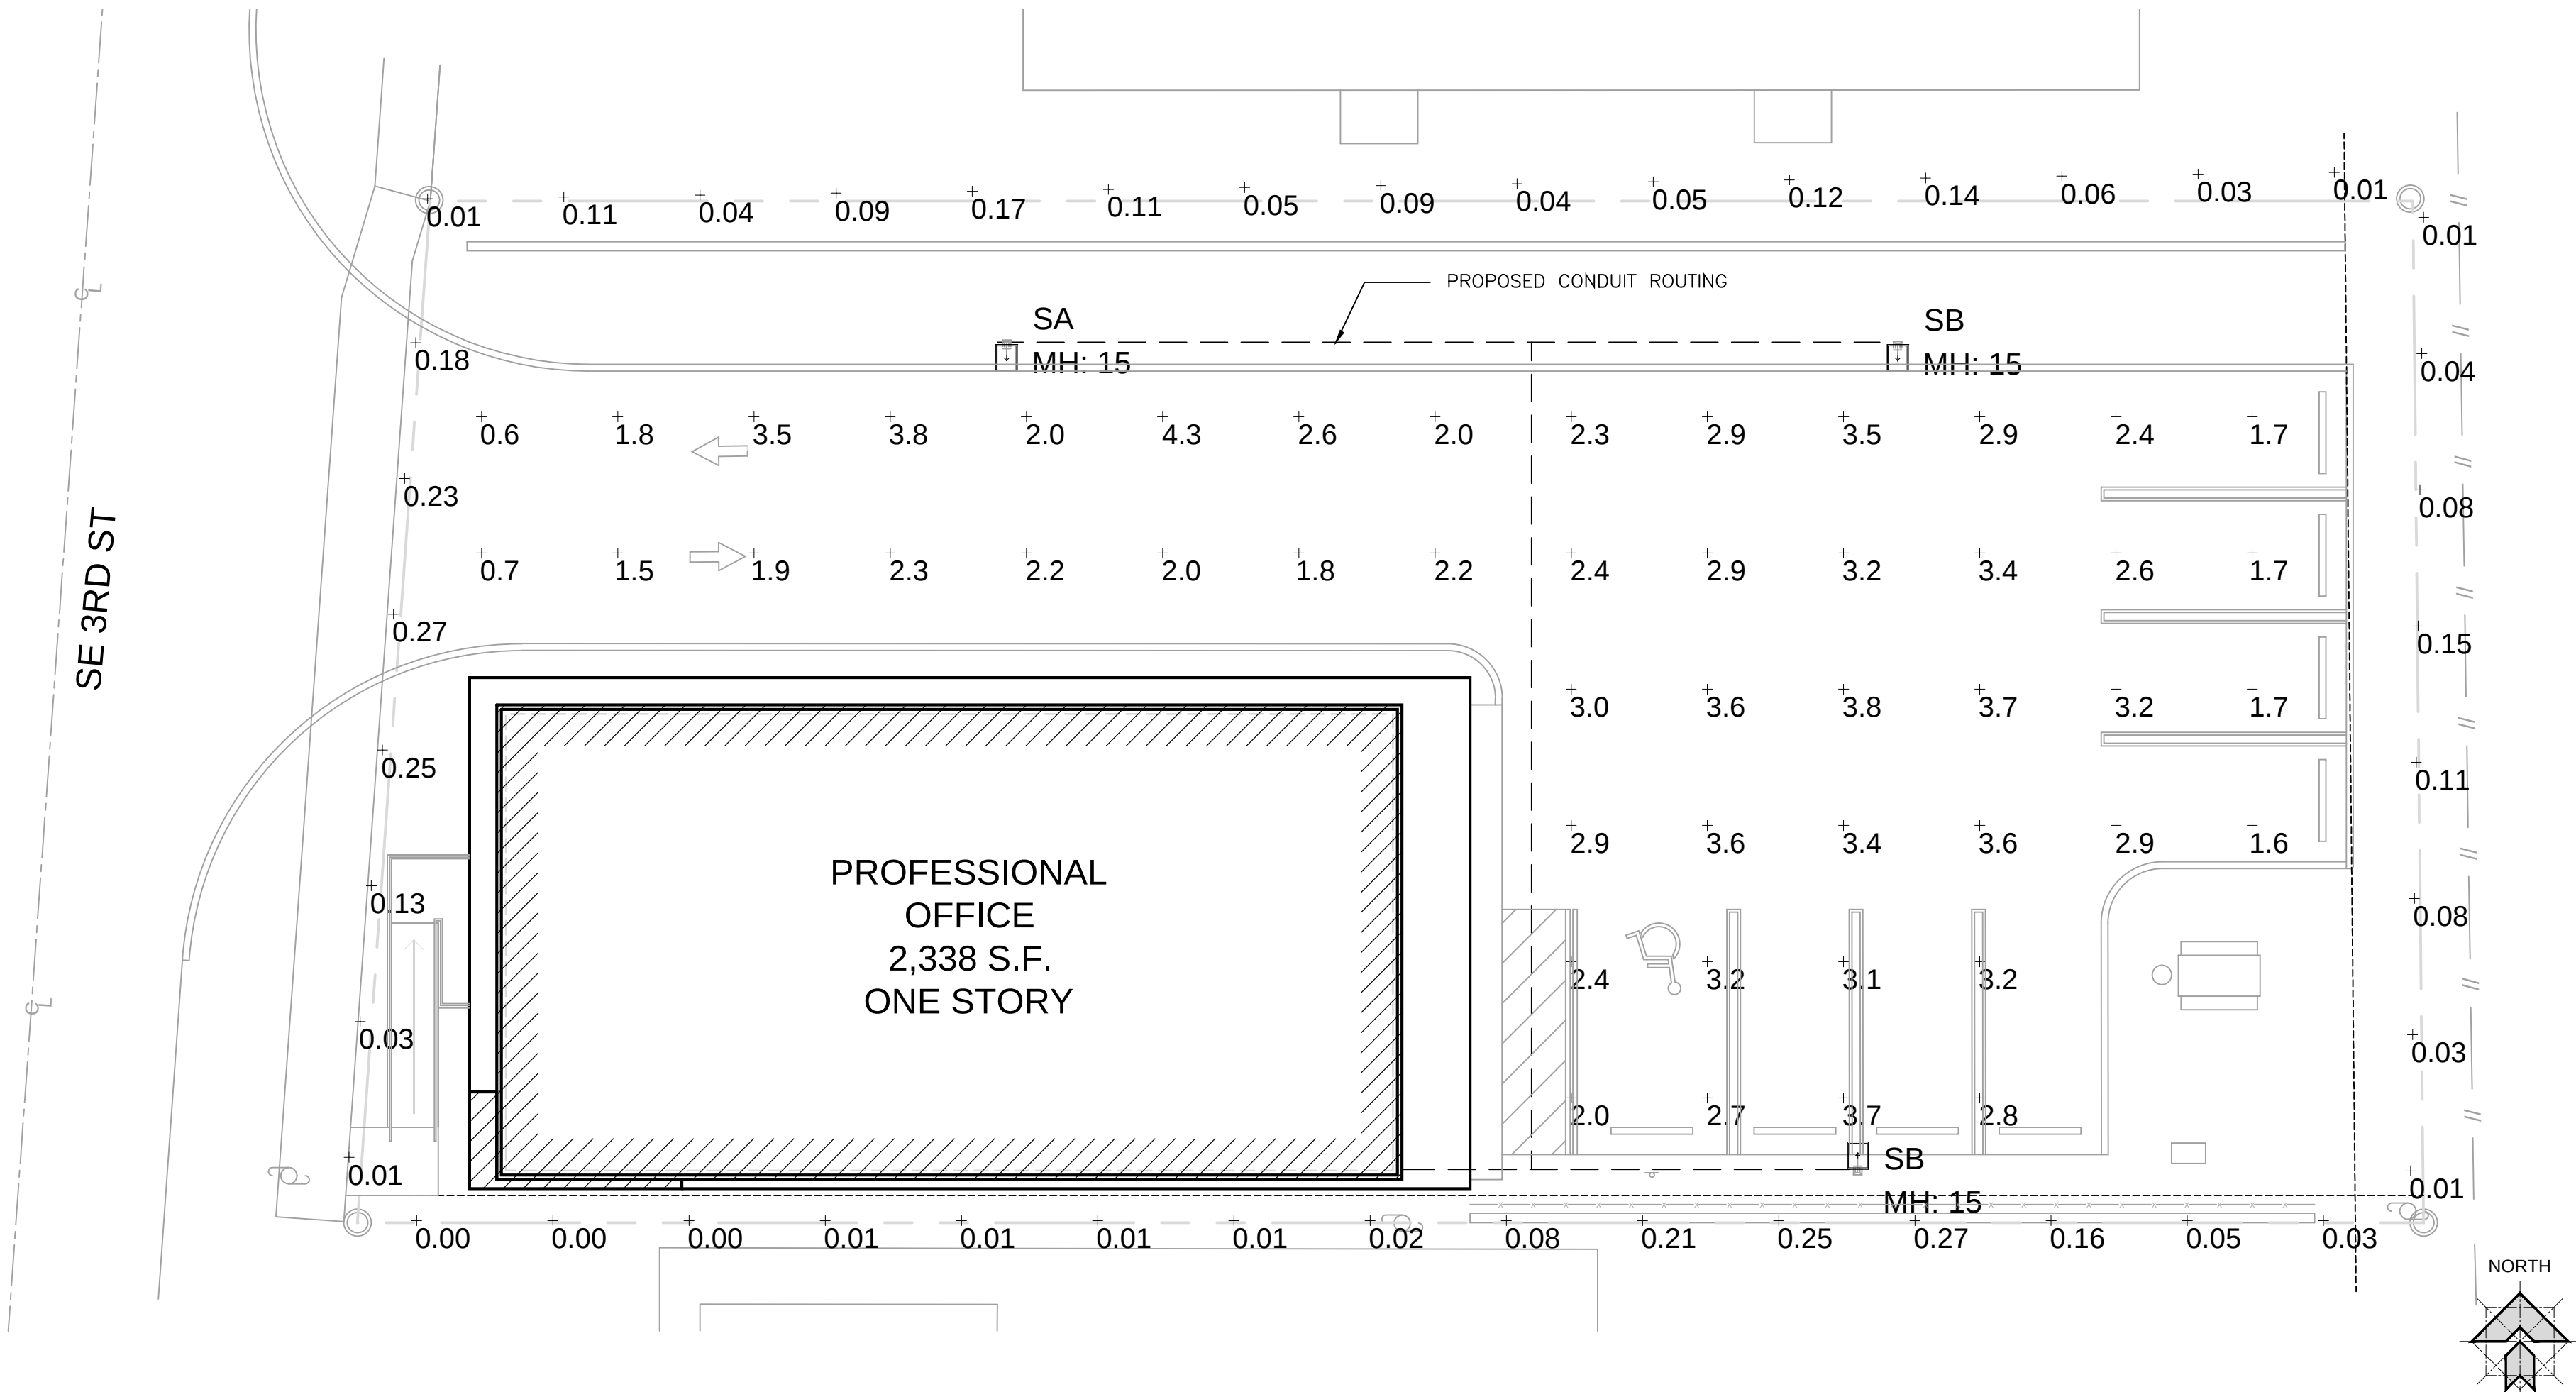


SITE LIGHTING PLAN

SCALE: 1" = 10'

1

COORDINATION
SITE PLAN UPDATED

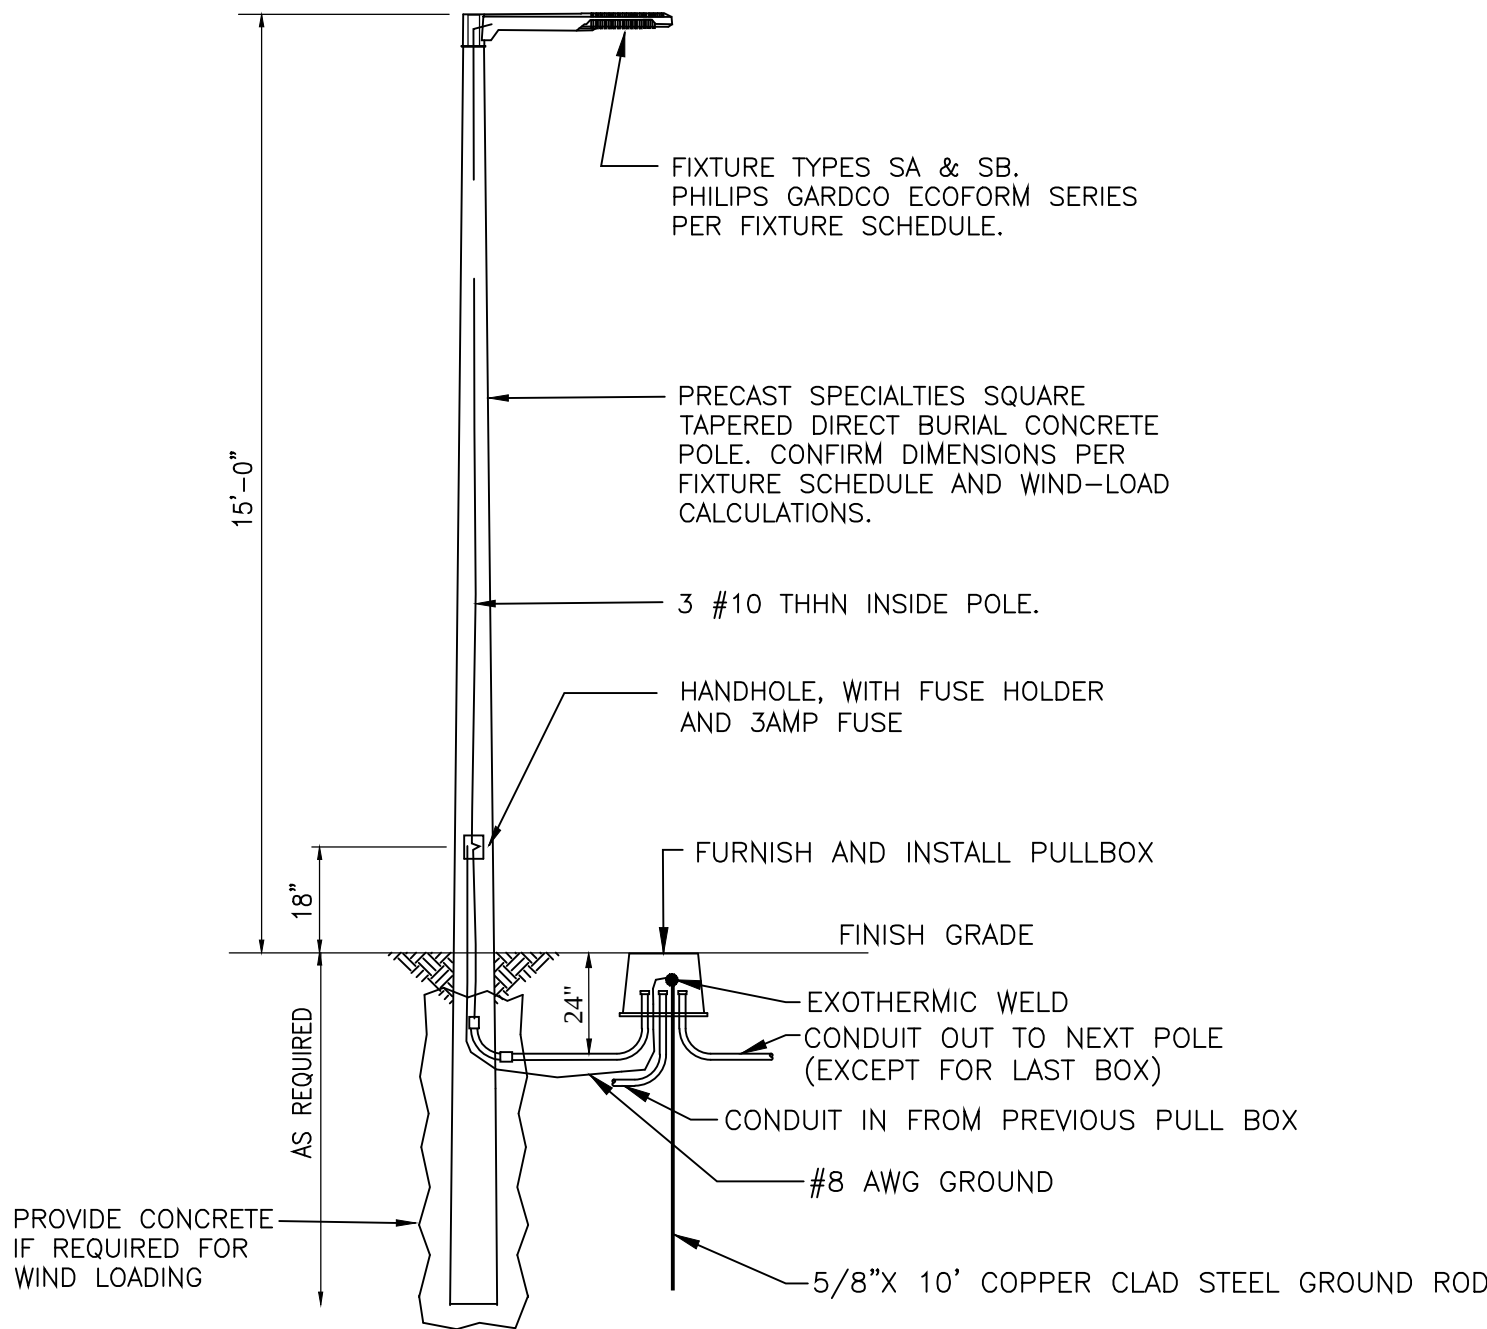

NOTE: DIRECT BURIAL POLE AND LUMINAIRES SHALL
COMPLY WITH THE F.B.C 5TH EDITION (2014) AND
SHALL WITHSTAND WINDLOADS OF 140 MPH

NOTE: PRIOR TO INSTALLATION CONTRACTOR SHALL
VERIFY THAT SITE LIGHTING POLES SHOWN ARE NOT
LOCATED IN THE AREA OF ANY UTILITY EASEMENTS.
IF ANY OF THE POLES SHOWN ARE LOCATED ON
ANY UTILITY EASEMENT, CONTRACTOR SHALL NOTIFY
ARCHITECT OF CONFLICT.


SITE LUMINAIRE MOUNTING DETAIL

SCALE: NTS

2


LUMINAIRE SCHEDULE														
Project: NURSE 1 SITE & PARKING 12-15-2016														
Symbol	Qty	Label	Description	Lumens/Lamp	LLD	LDD	BF	LLF	Lum. Watts	Total Watts	Material	Color	Mounting Height	Size (LxWxD)
	1	SA	PHILIPS GARDCO ECF-3-75LA-4853-NW-IS POLE MOUNT 15' AFG	N.A.	0.900	0.900	1.000	0.810	77.4	77.4	Die Cast Aluminum	Mill Finish	15 feet	24.2" x 13" x2.1"
	2	SB	PHILIPS GARDCO ECF-4-75LA-4853-NW-IS POLE MOUNT 15' AFG	N.A.	0.900	0.900	1.000	0.810	77.4	154.8	Die Cast Aluminum	Mill Finish	15 feet	24.2" x 13" x2.1"

CALCULATION SUMMARY							
Project: NURSE 1 SITE & PARKING 12-15-2016							
Label	CalcType	Units	Avg	Max	Min	Avg/Min	Max/Min
PROPERTY LINE	Illuminance	Fc	0.09	0.27	0.00	N.A.	N.A.
SITE & PARKING_Planar	Illuminance	Fc	2.65	4.3	0.6	4.42	7.17

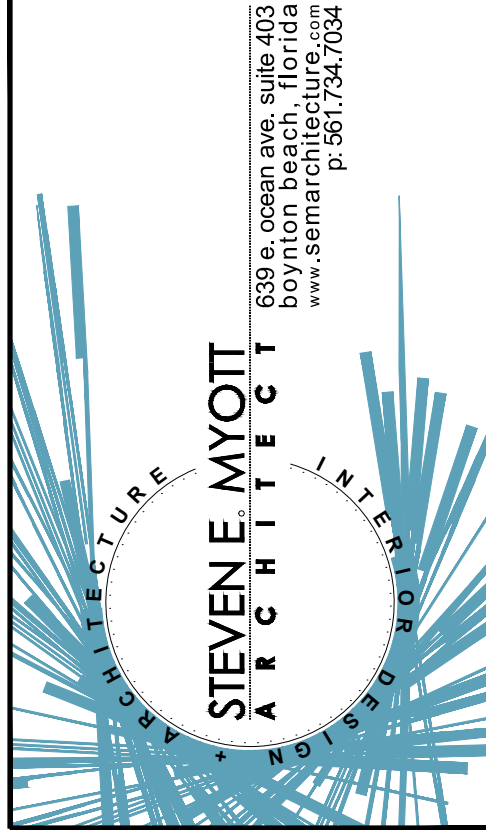

NURSE 1
- SITE PLAN APPROVAL -

SE 3RD ST
BOYNTON BEACH, FLORIDA

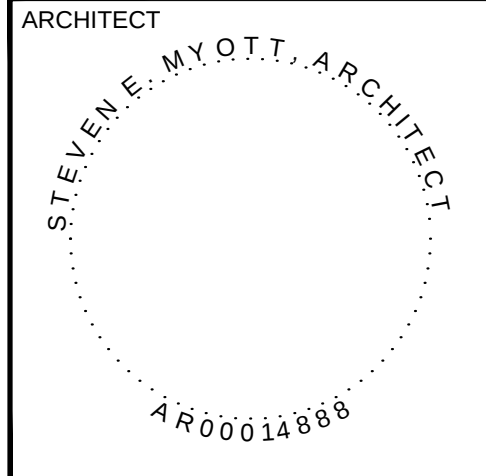

ALL DRAWINGS AND WRITTEN MATERIAL
APPEARING HEREIN CONSTITUTE ORIGINAL AND
UNPUBLISHED WORK OF THE ARCHITECT AND
MAY NOT BE USED, DUPLICATED OR DISCLOSED
IN ANY FORM WITHOUT THE EXPRESSED
WRITTEN CONSENT OF THE ARCHITECT

PROJECT NO: 16.093
DRAWN BY: MB
CHECKED BY: SM

NO. DATE: ISSUED FOR:
1 02/04/2016 SITE PLAN APPROVAL
2 02/13/2017 SITE PLAN COMMENTS
3 03/06/2017 DARI COMMENTS

SITE
LIGHTING
PLAN

SL-1